


ILS-3600-0IR/2600-0IR

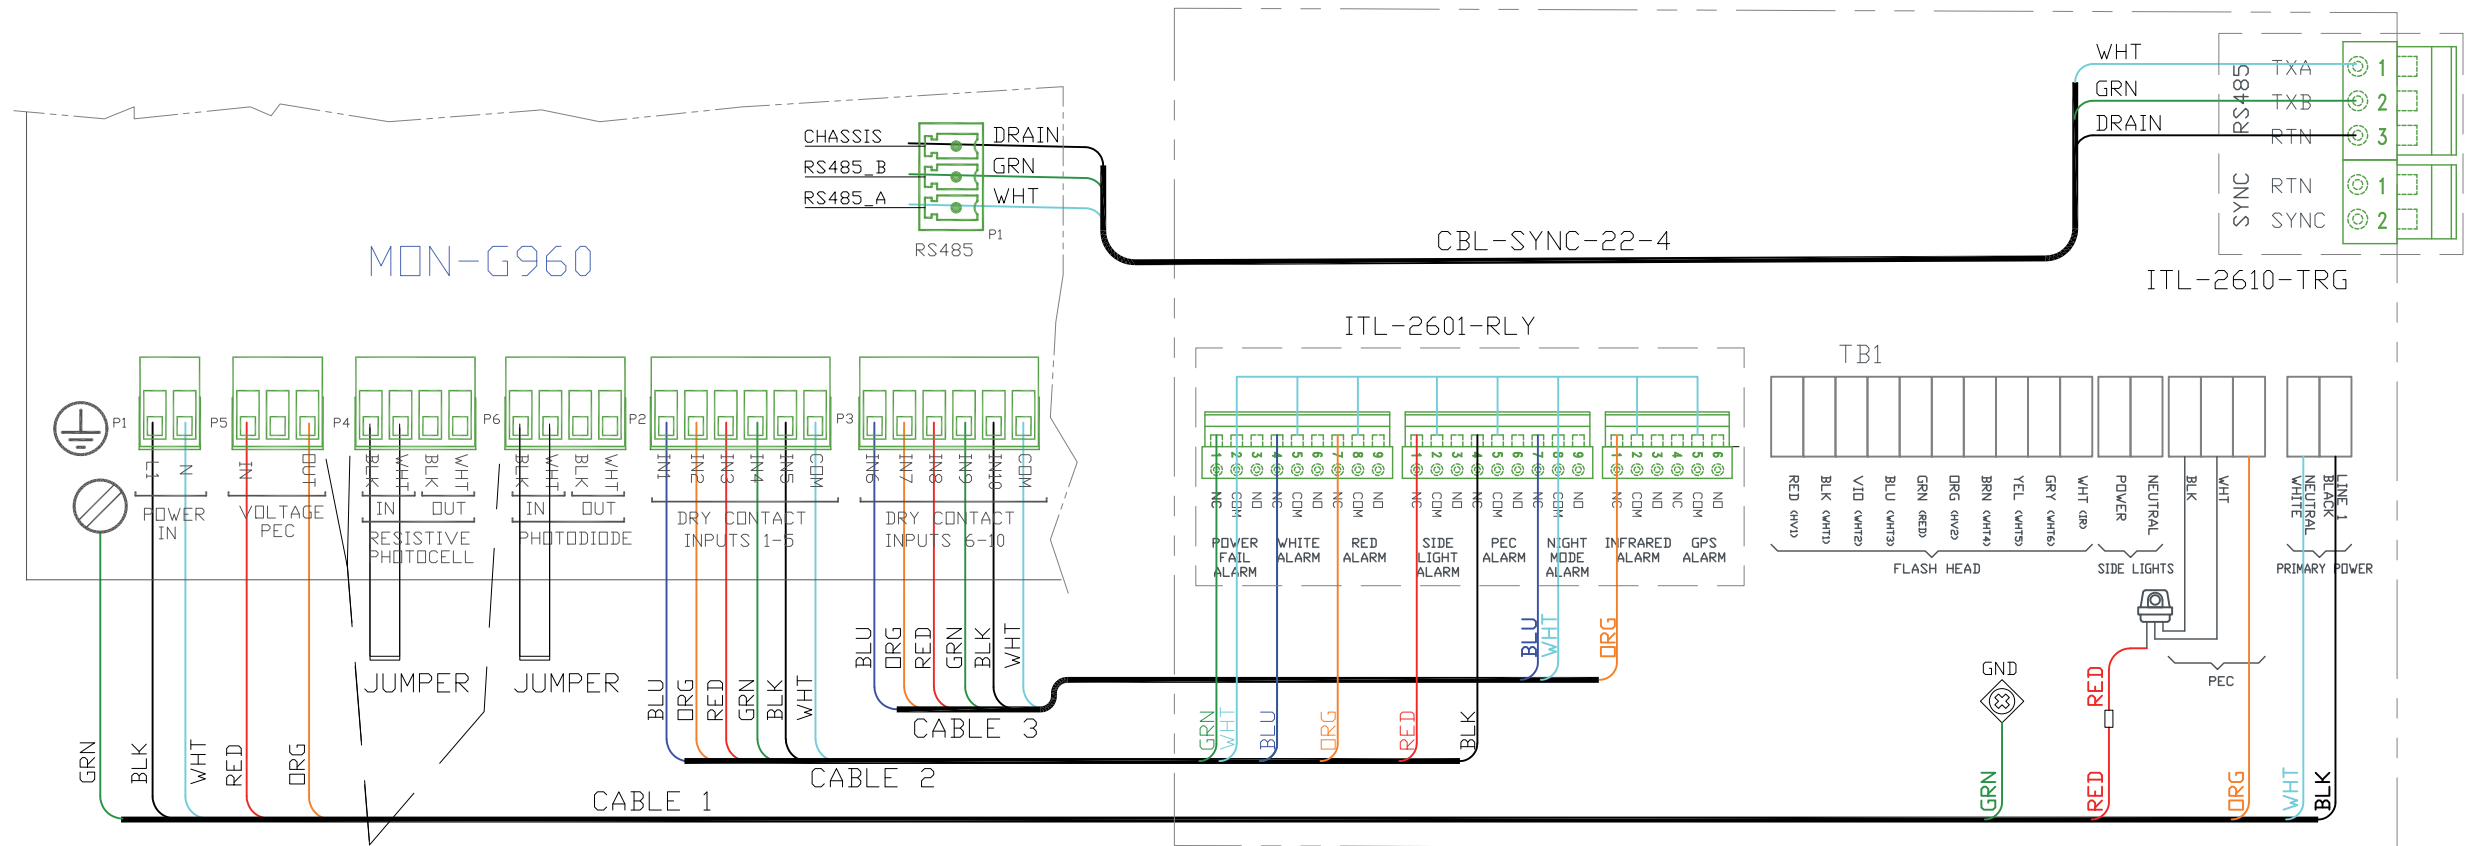

NOTE: VERIFY P4/P5/P6 WIRING BEFORE
CONNECTING LIGHTING SYSTEM. VERIFY
MON-G960 FUSE F2 IS INSTALLED.

REV		DATE	DESCRIPTION		REVISED BY	APPROVED
NOTICE The drawing, information, and subject matter hereof are the exclusive, sole, and confidential property of International Tower Lighting, LLC and may not be copied, reproduced, or used in any manner for any purpose whatsoever without written consent or direction from International Tower Lighting, LLC .	1001 Centre Pointe Drive, Suite A La Vergne, TN 37086, USA Tel.+1 615-256-6030 Fax +1 615-256-6032 www.itl-llc.com					
	DRAWN EHI	5/9/2019				
	CHECKED AI	5/9/2019	TITLE			
	QA		WIRING DIAGRAM MON-G960 TO ILS-3600-0IR/2600-0IR E1 SYSTEM			
	MFG					
	APPROVED					
	PLOT DATE	5/9/19	SIZE B	DWG NO DOC-MON-G960-WD-ILS3(2)6000IR-E1	REV 0	
	FILENAME DDC-MON-G960-WD-ILS3(2)6000IR-E1 R0.DWG	SCALE		SHEET		