


D-2/3LVS

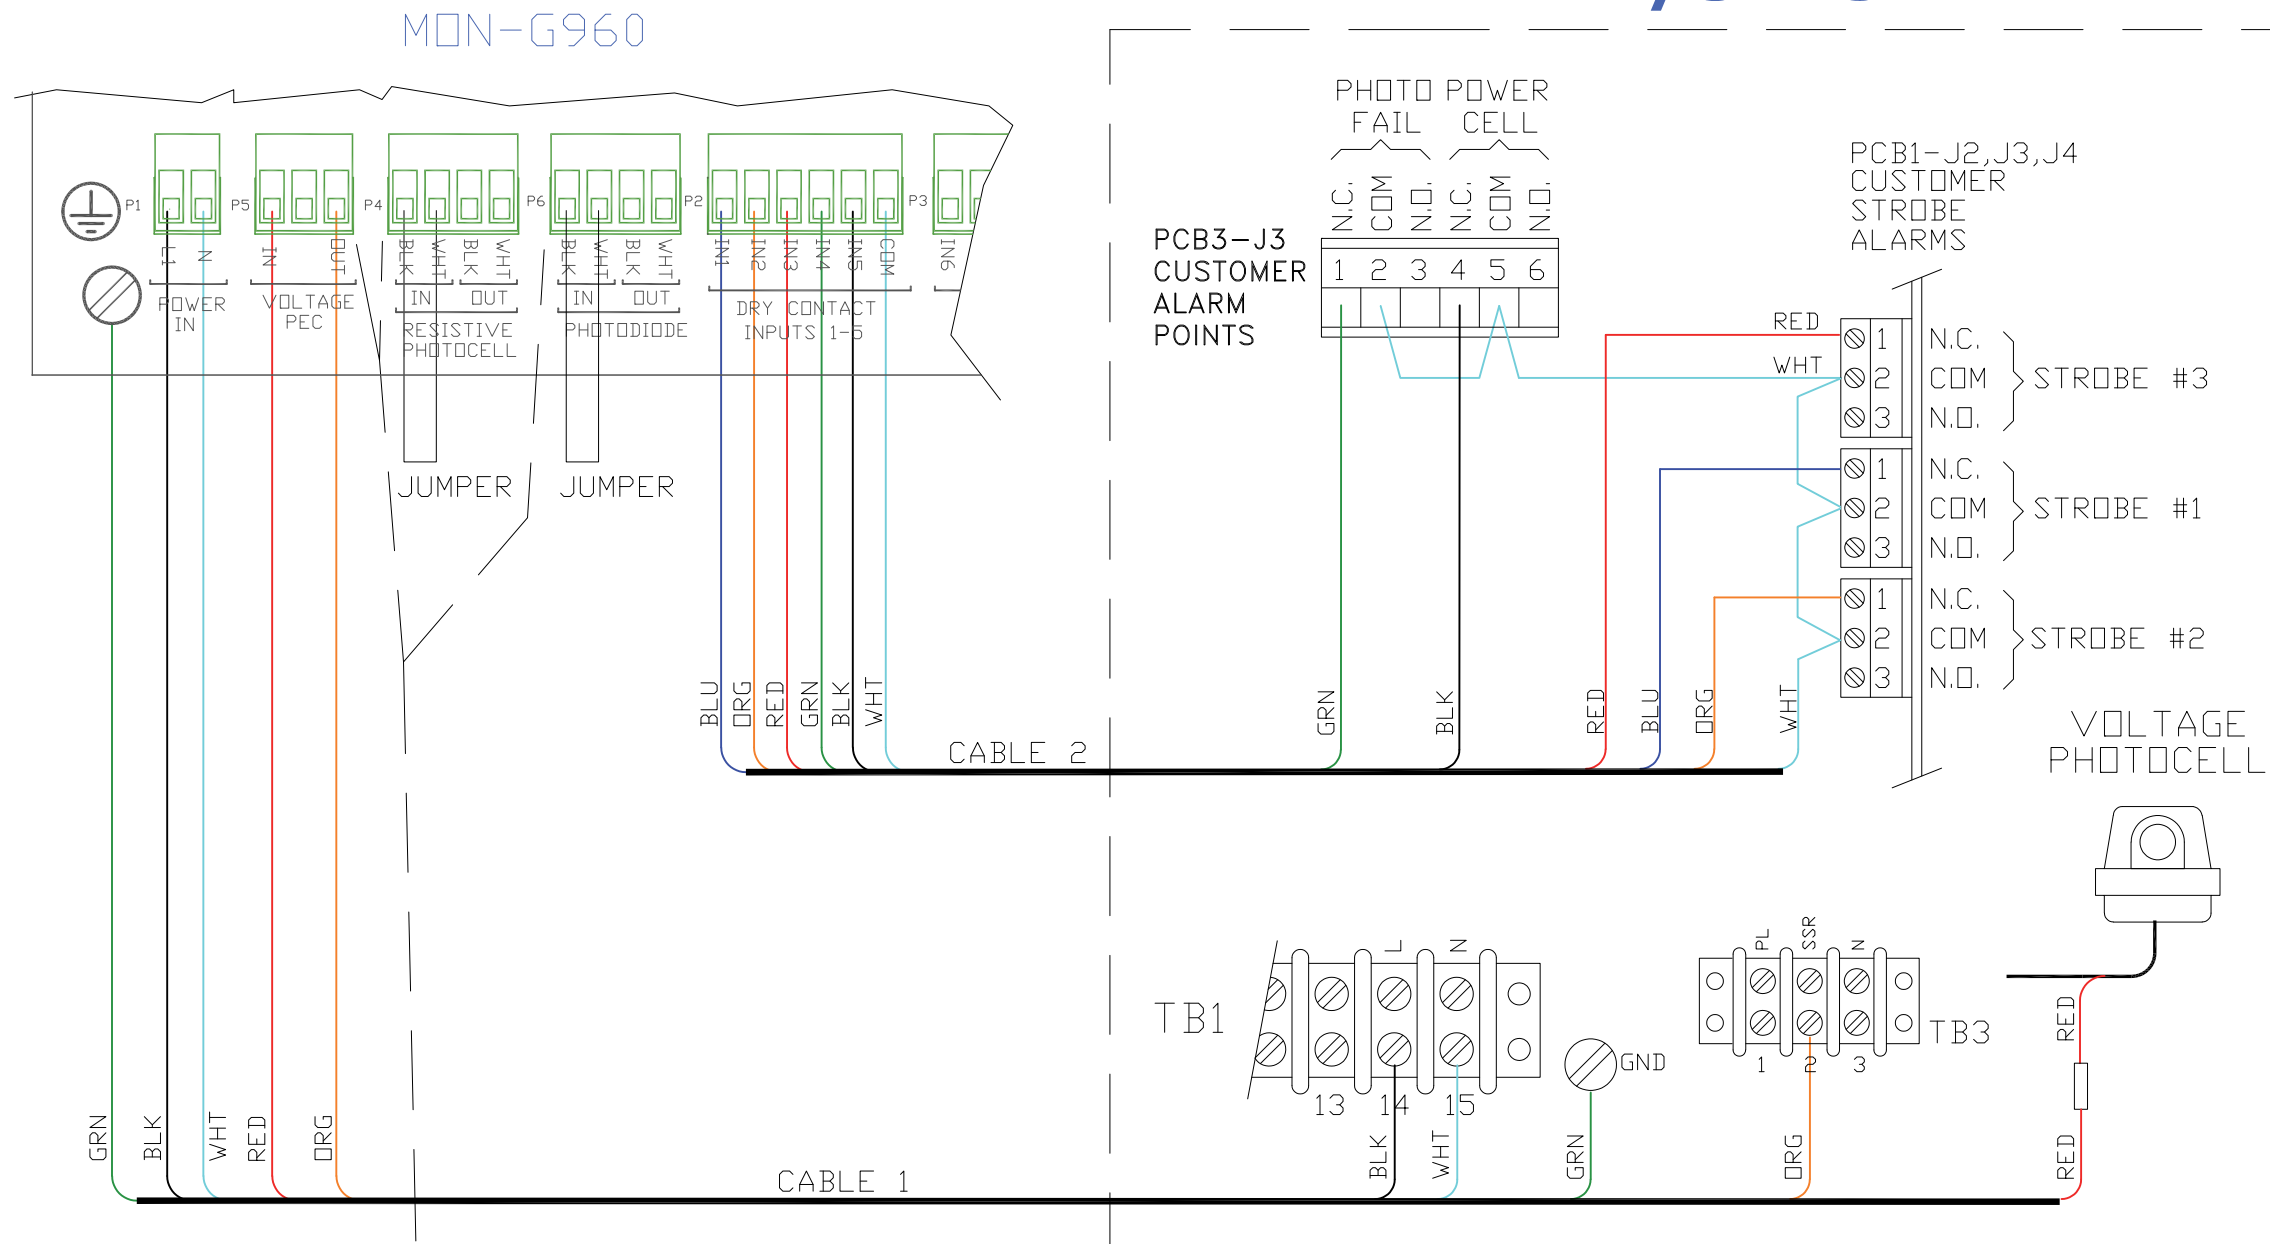

NOTE: VERIFY P4/P5/P6 WIRING BEFORE
CONNECTING LIGHTING SYSTEM. VERIFY
MON-G960 FUSE F2 IS INSTALLED.

NOTICE The drawing, information, and subject matter hereof are the exclusive, sole, and confidential property of International Tower Lighting, LLC and may not be copied, reproduced, or used in any manner for any purpose whatsoever without written consent or direction from International Tower Lighting, LLC .	REV	DATE	DESCRIPTION		REVISED BY	APPROVED
	1001 Centre Pointe Drive, Suite A La Vergne, TN 37086, USA Tel.+1 615-256-6030 Fax +1 615-256-6032 www.itl-llc.com					
	DRAWN EHI	5/9/2019				
	CHECKED AI	5/9/2019				
	QA					
	MFG					
	APPROVED		TITLE WIRING DIAGRAM MON-G960 TO D-2/3LVS			
	PLOT DATE	5/9/19				
FILENAME DDC-MON-G960-WD-D-2-3LVS R0.DWG		SIZE B	DWG NO DOC-MON-G960-WD-D-2-3LVS	REV 0		
		SCALE		SHEET		